



RAAF Base Edinburgh, Adelaide

- 116. Joint Logistics Unit (South) Precinct Plan
- 117. Joint Logistics Unit (South) Workshop Floor Plan
- 118. Joint Logistics Unit (South) Armoury Floor Plan

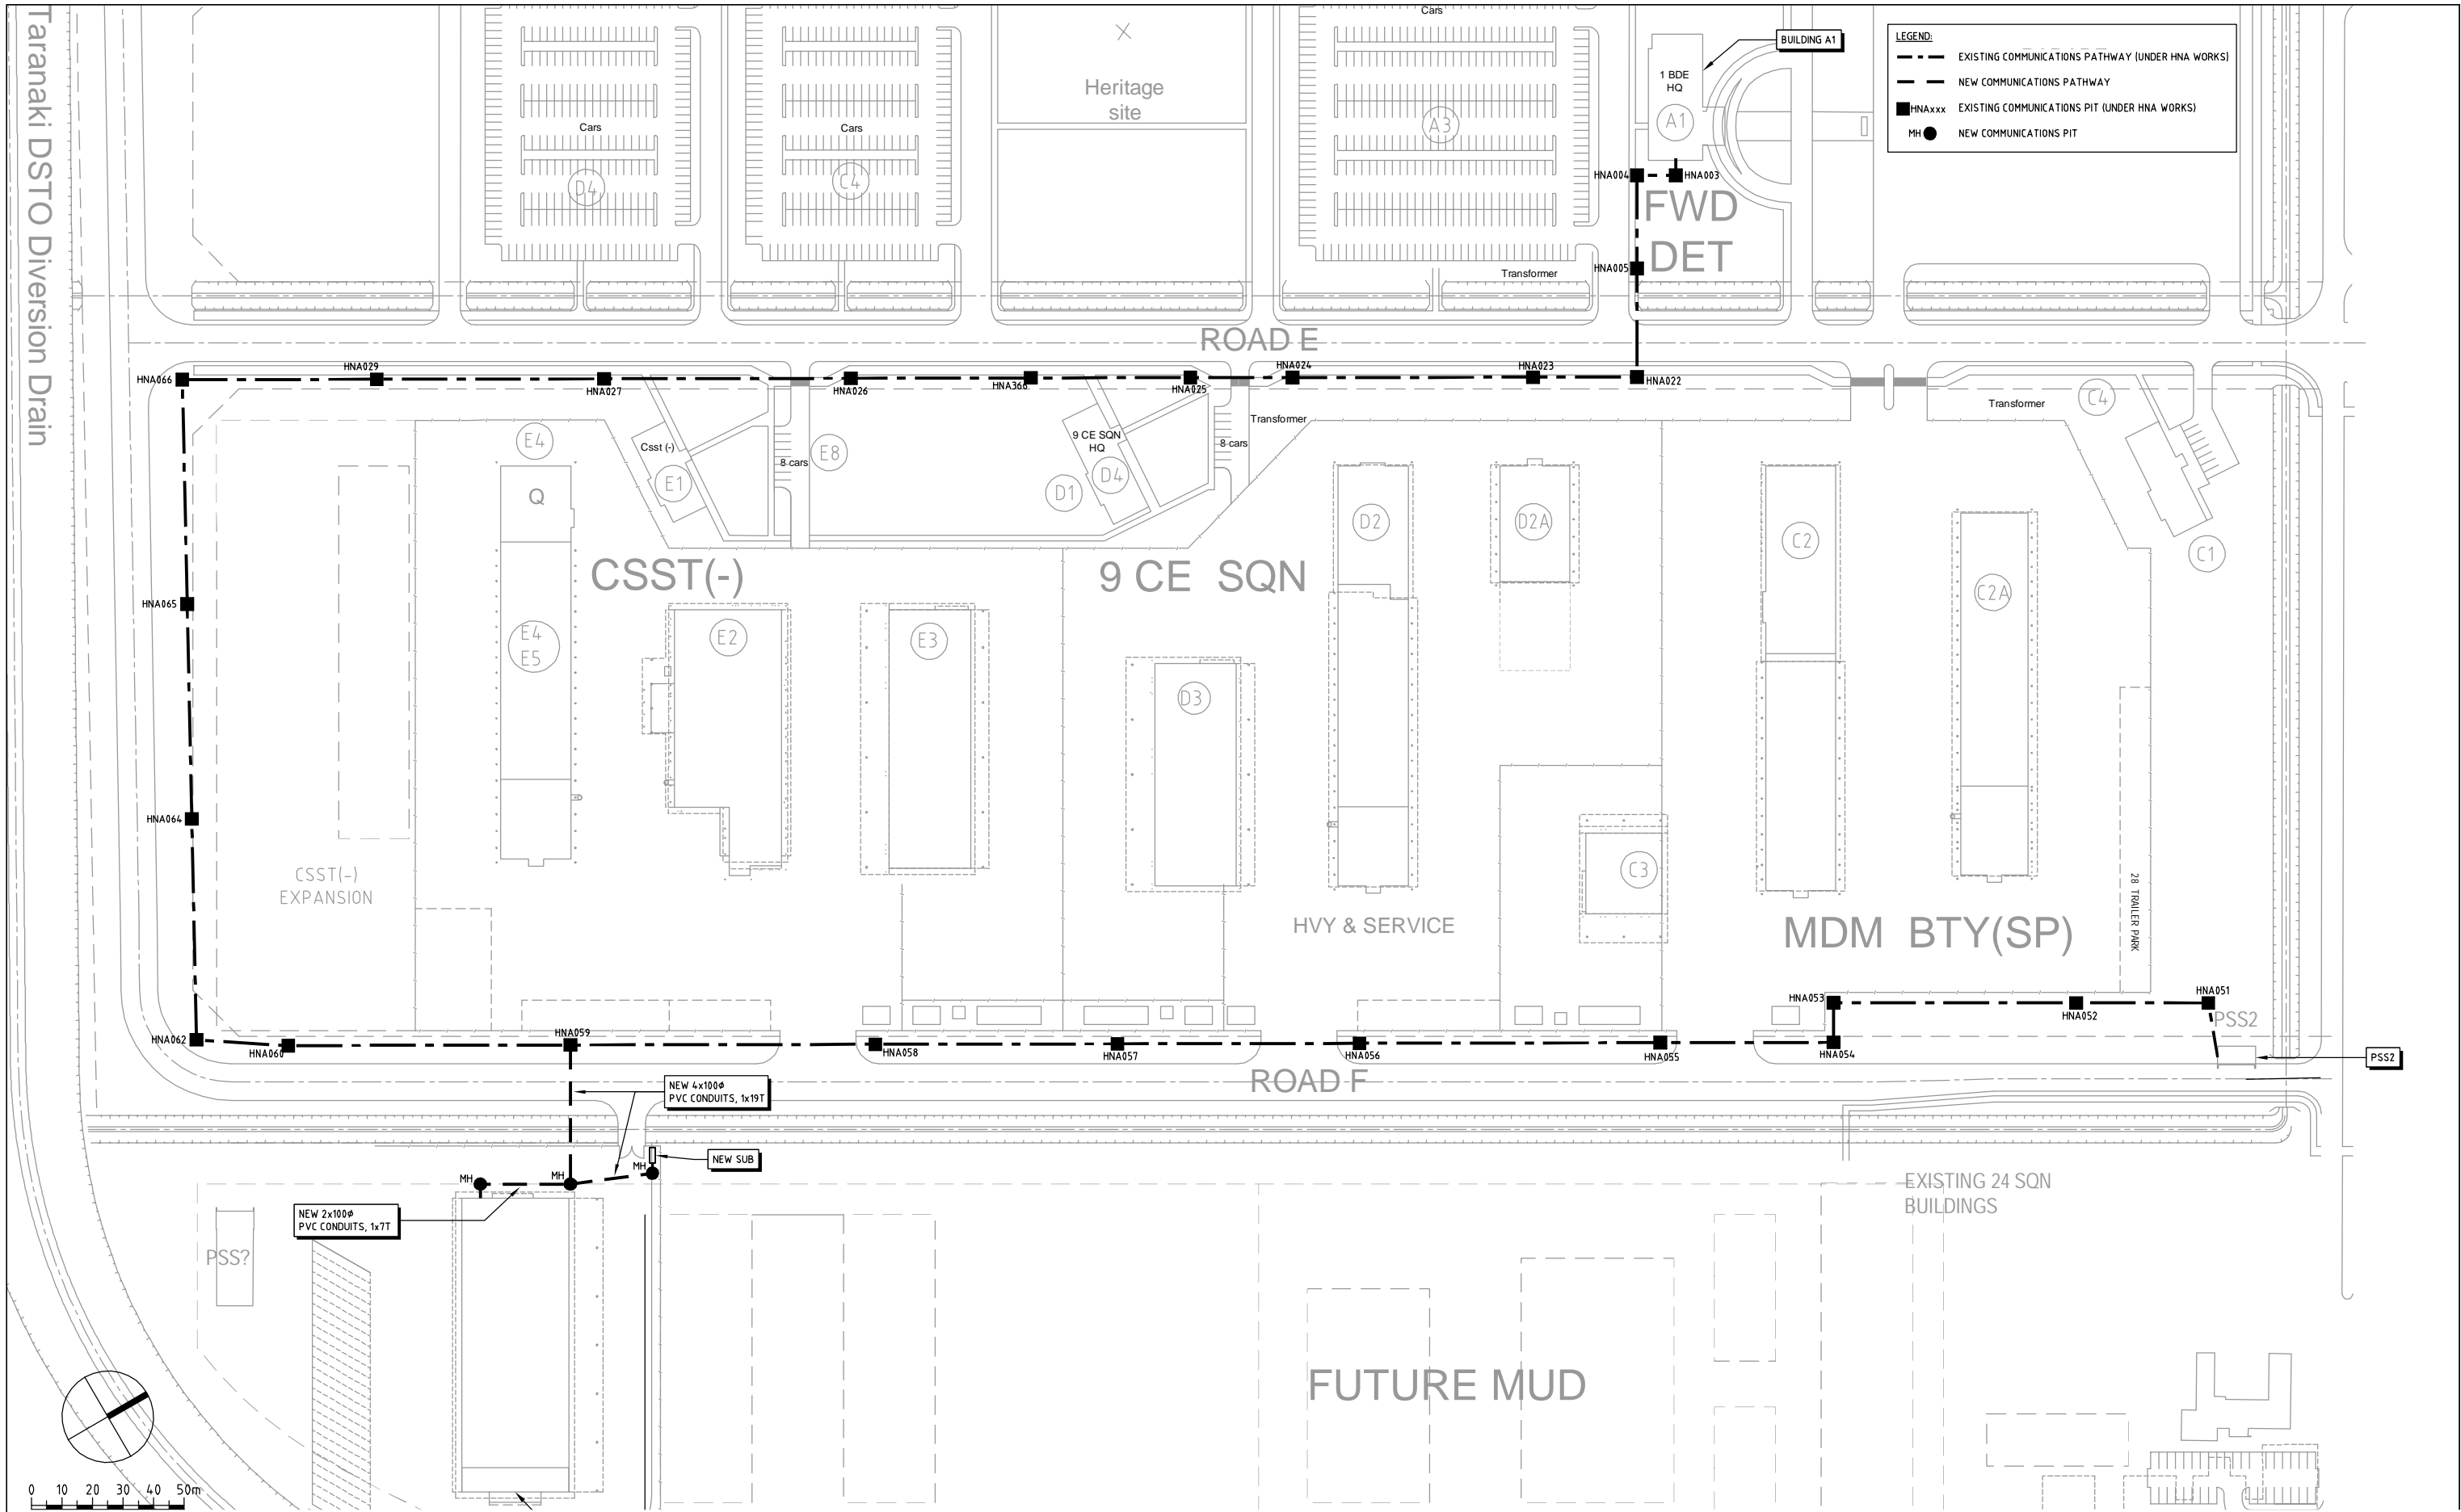

Attachment 116

Joint Logistics Unit (South) Precinct Plan

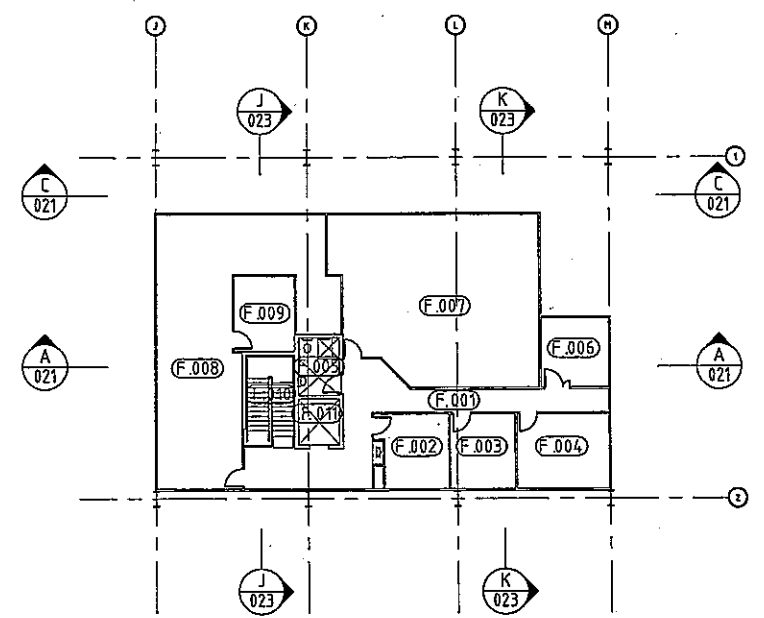



ROOM NAME LEGEND

- F.001 CORRIDOR
- F.002 OFFICE 01
- F.003 OFFICE 02
- F.004 DEFENCE OFFICE
- F.005 ACCESS/UNISEX TOILET
- F.006 COMMS
- F.007 LUNCH/TRAINING
- F.008 CONTRACTORS OFFICE
- F.009 CONTRACTORS MANAGER'S OFFICE
- F.010 STAIRS
- F.011 LIFT

FIRST FLOOR PLAN SCALE 1:200


ROOM NAME LEGEND

 - G.001 ENTRY
- G.002 RECEPTION
- G.003 MECHANICAL CONTRACTORS
- G.004 AIR-CONDITIONING PLANT
- G.005 CONDENSING UNITS
- G.006 BATTERY CHARGE & STORAGE AREA
- G.007 EIR WORKSHOP
- G.008 COMMS NFE STORE
- G.009 TECH/ELEC WORKSHOP
- G.010 ACCESS
- G.011 AIR-LOCK
- G.012 FEMALE TOILETS/CHANGE ROOM
- G.013 LIFT
- G.014 CLEANER
- G.015 STAIRS
- G.016 AIR-LOCK
- G.017 MALE TOILETS/CHANGE ROOM
- G.018 CORRIDOR
- G.019 KITCHEN
- G.020 RPS STORE
- G.021 RPS OFFICE
- G.022A VEHICLE MAINTENANCE 01
- G.022B VEHICLE MAINTENANCE 02
- G.022C VEHICLE MAINTENANCE 03
- G.022D VEHICLE MAINTENANCE 04
- G.022E VEHICLE MAINTENANCE 05
- G.022F VEHICLE MAINTENANCE 06
- G.022G VEHICLE MAINTENANCE 07
- G.022H VEHICLE MAINTENANCE 08
- G.022J VEHICLE MAINTENANCE 09
- G.022K VEHICLE MAINTENANCE 10
- G.023A GENERAL ENGINEERING 01
- G.023B GENERAL ENGINEERING 02
- G.024 WELDING BAY
- G.025 WELDING STORE
- G.026 MARINE TESTING
- G.027 SPRINKLER VALVE ROOM
- G.028 SERVICE BAY 01
- G.029 SERVICE BAY 02
- G.030 NO LONGER USED
- G.031 OIL AND SEPARATOR ROOM
- G.032 COMPRESSOR ROOM
- G.033 P.O.L ROOM
- G.034 EXTERNAL GAS BOTTLE STORAGE
- G.035 EXTERNAL AREA 1
- G.036 EXTERNAL AREA 2

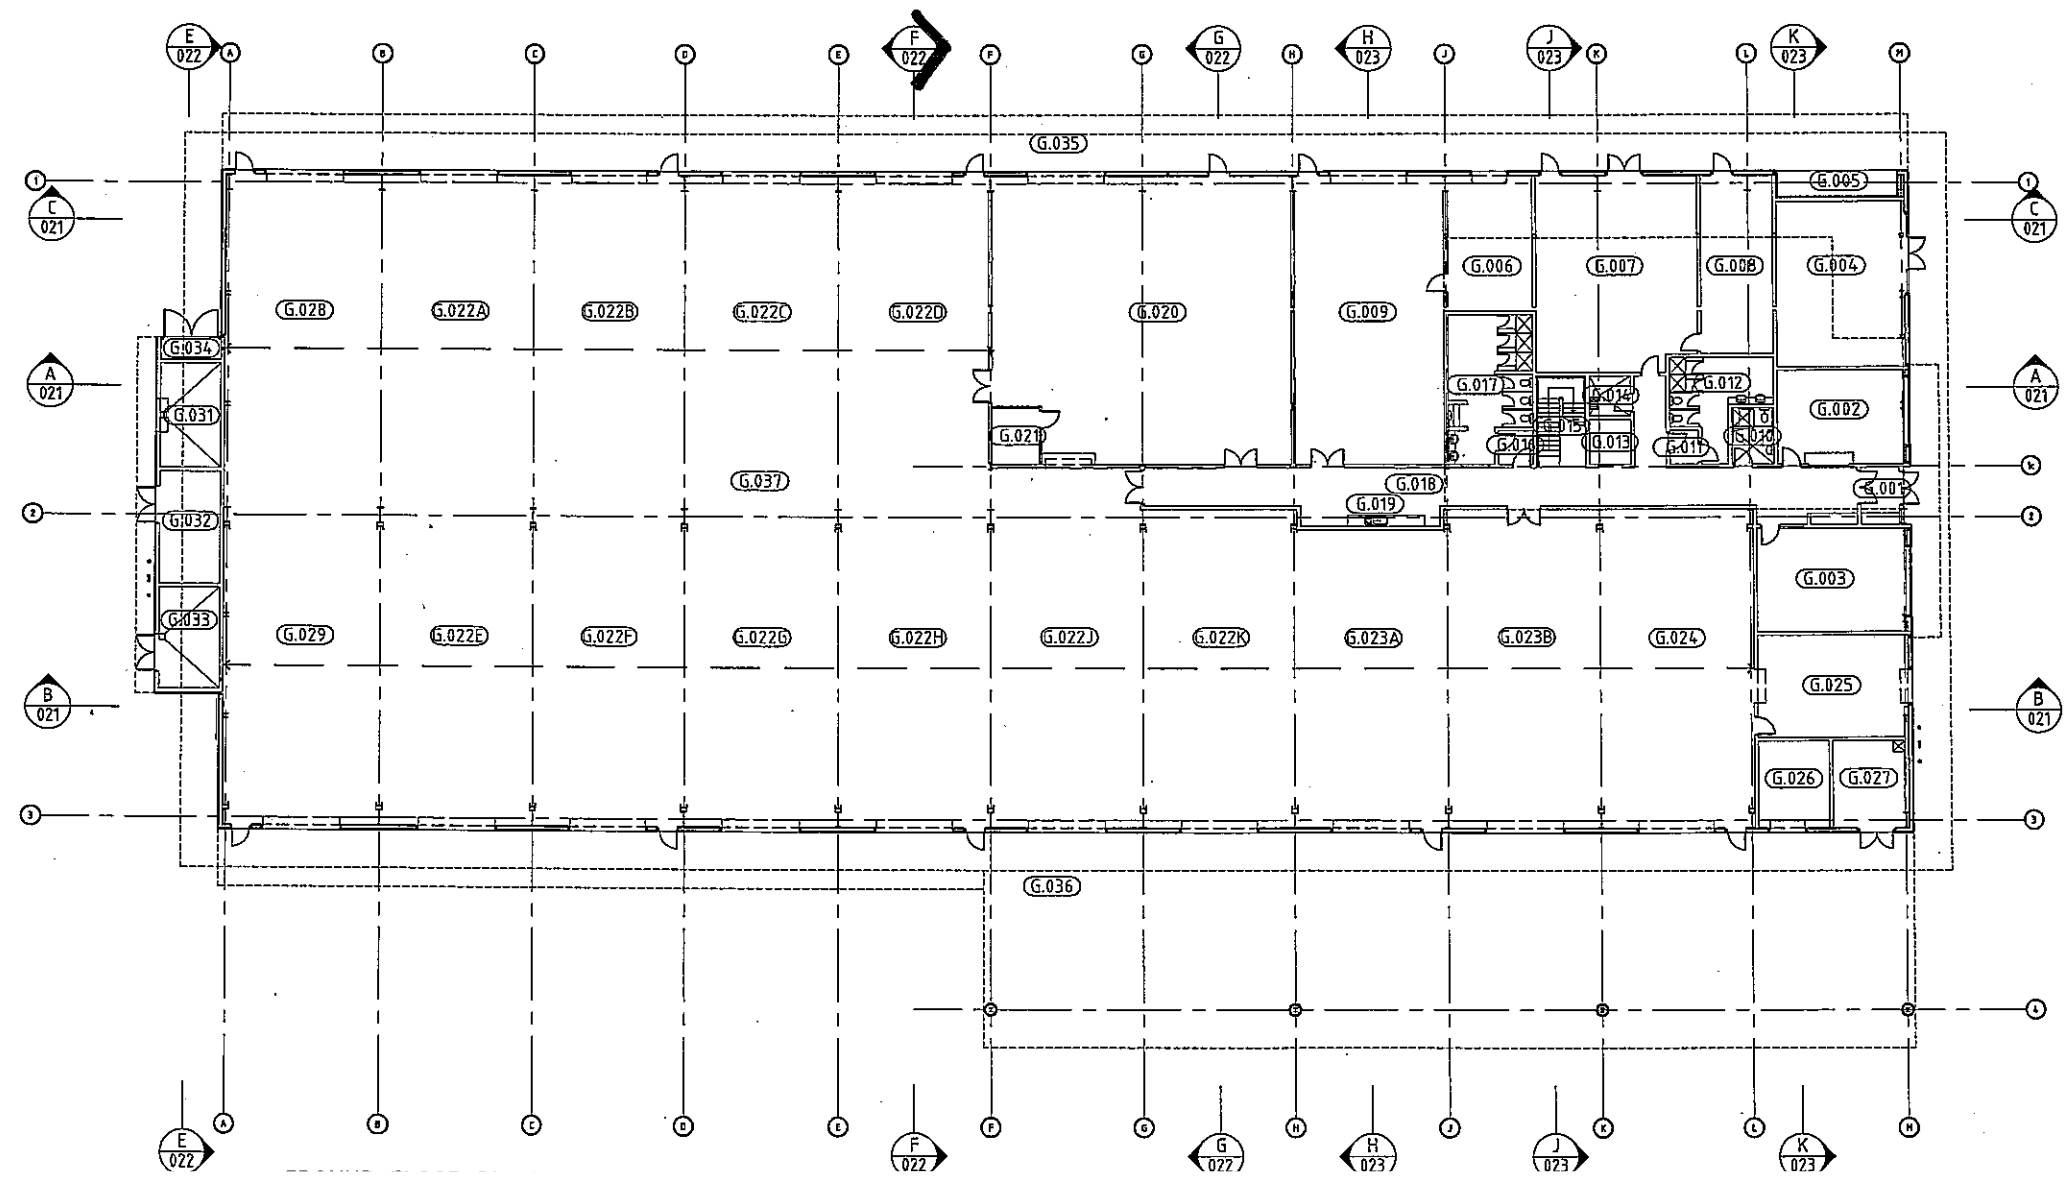

Attachment 117

Joint Logistics Unit (South) Workshop Floor Plan

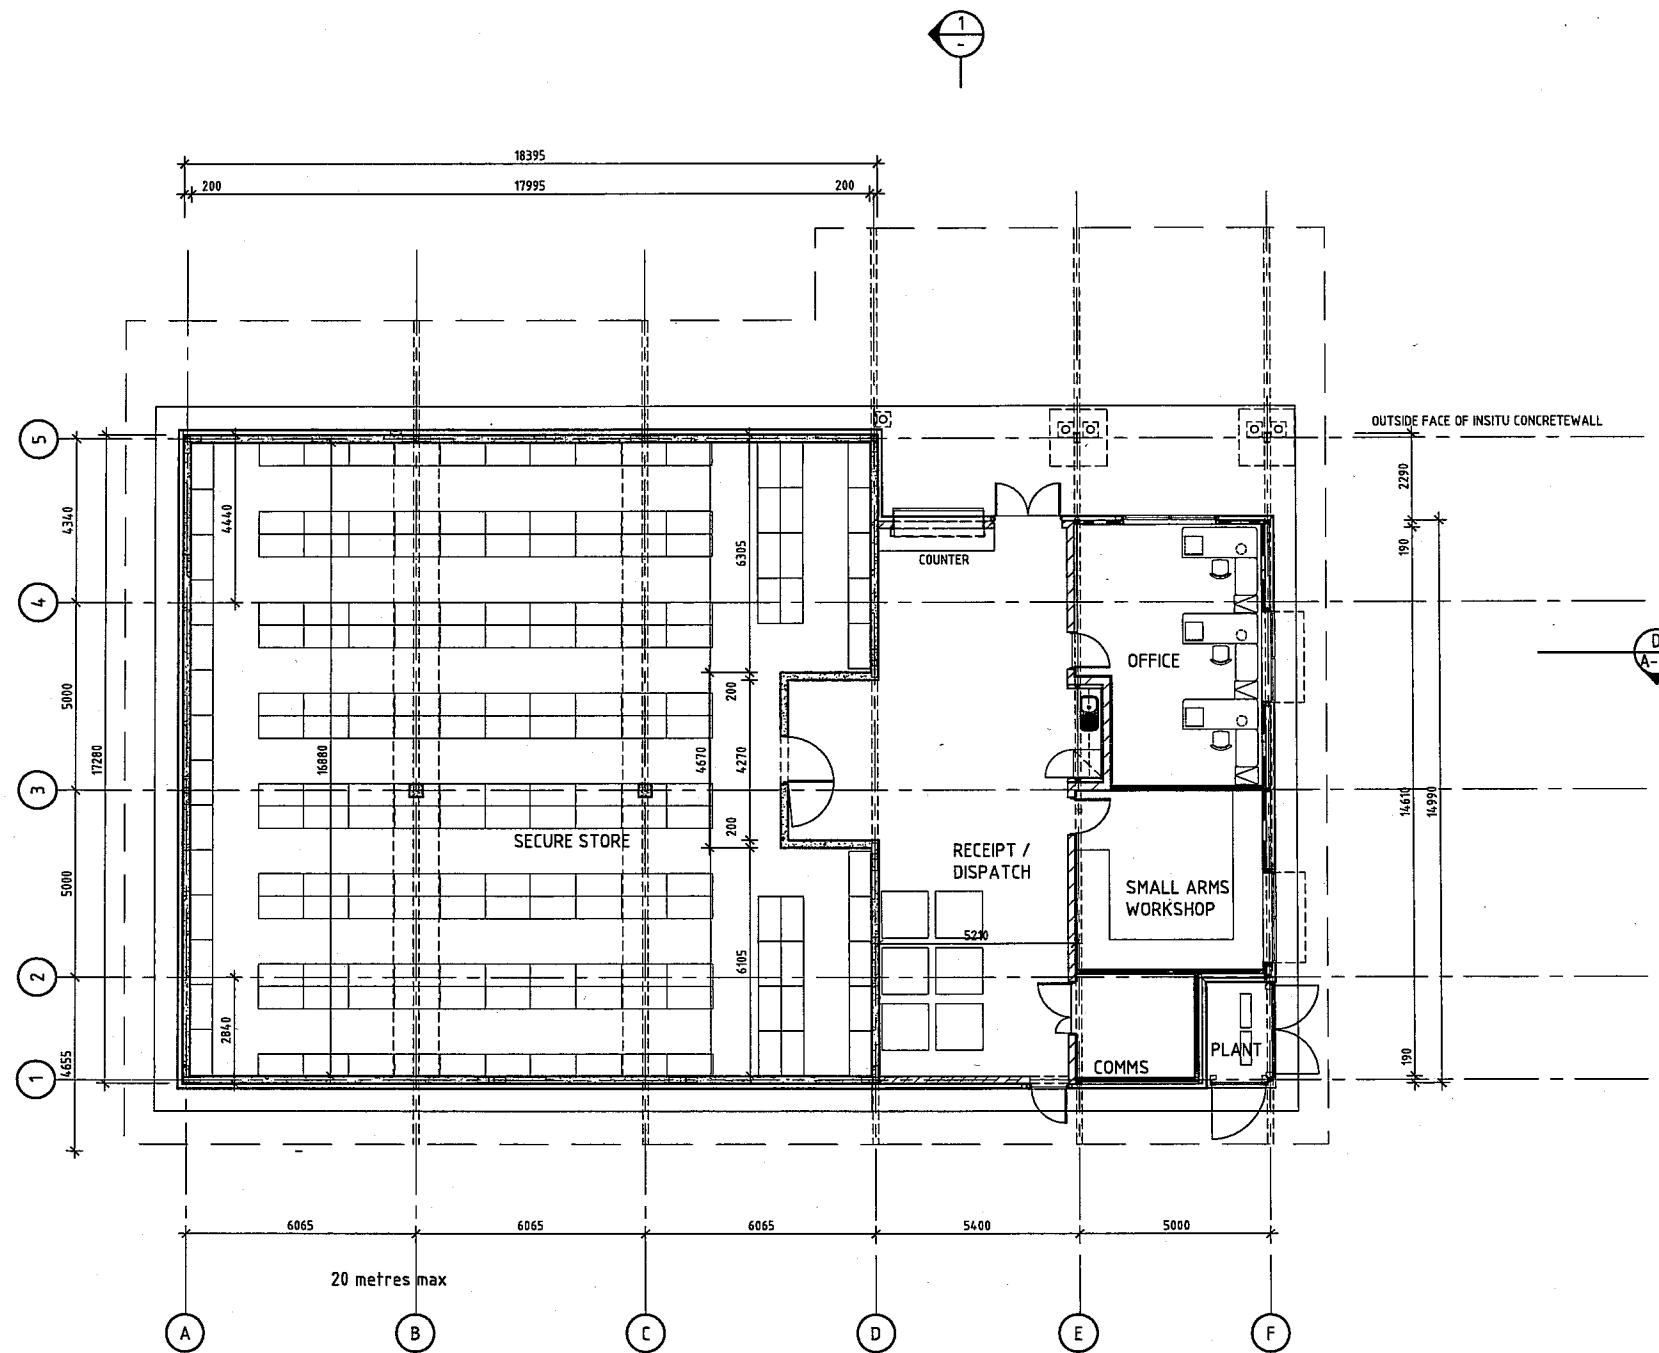

FLOOR PLAN
SCALE 1:200 (AT A1 SIZE)

Attachment 118

Joint Logistics Unit (South) Armoury Floor Plan